



**ROOF LEVEL PLAN - A THRU E**  
SCALE: 1" = 20'-0"

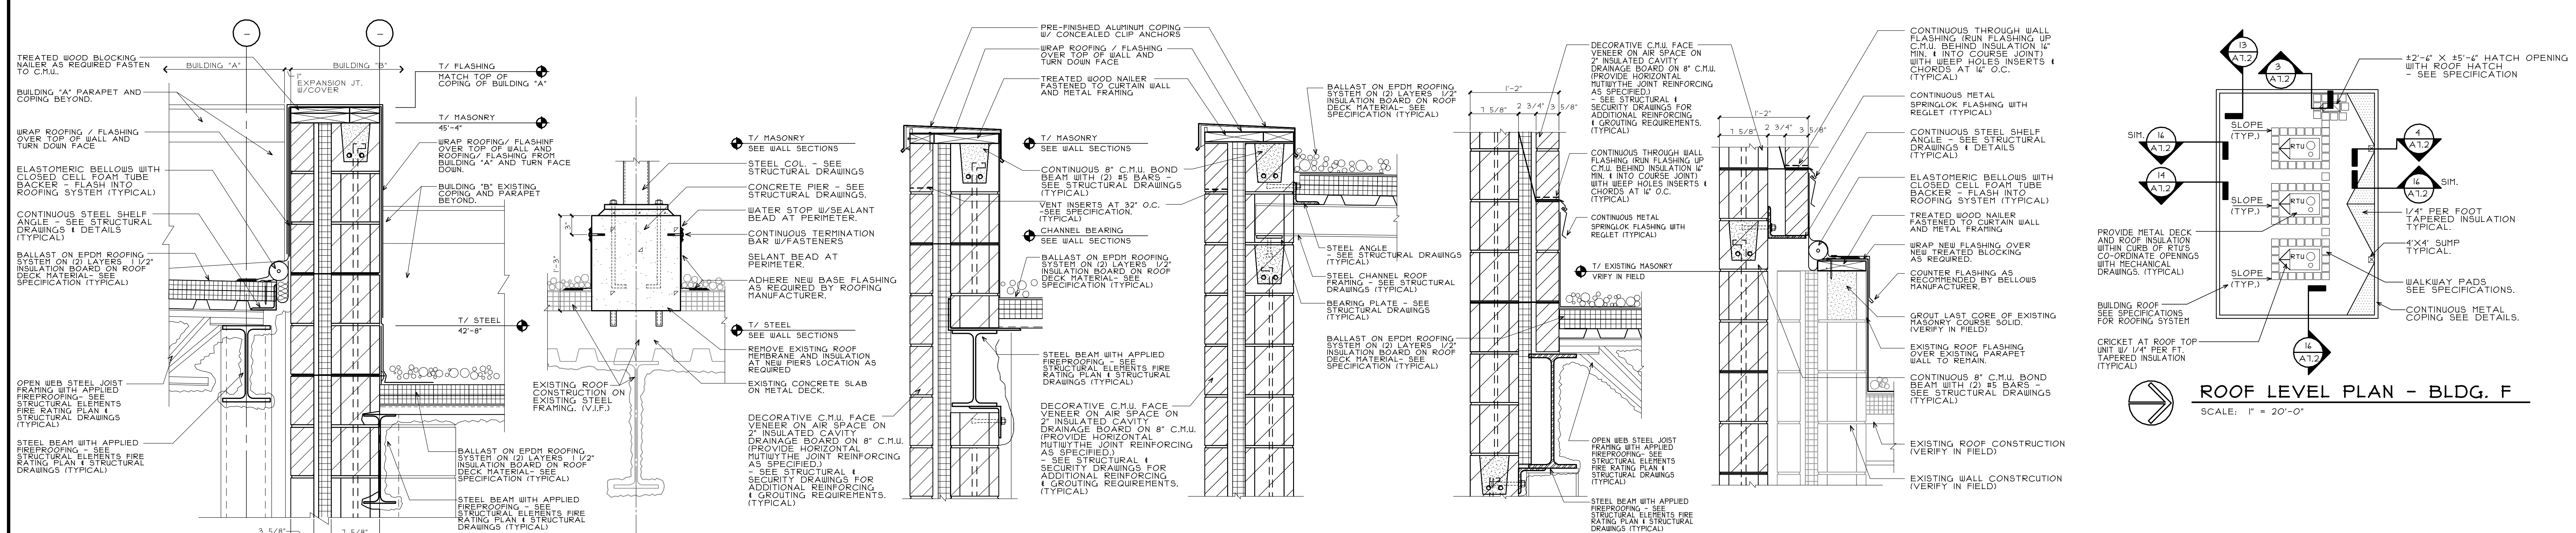

**ROOF LEVEL PLAN - BLDG. F**  
SCALE: 1" = 20'-0"

- 4 **ROOF DETAIL** SCALE: 1 1/2" = 1'-0"
- 5 **ROOF DETAIL AT EQUIP. CONCRETE PIER** SCALE: 1 1/2" = 1'-0"
- 1 **ROOF DETAIL** SCALE: 1 1/2" = 1'-0"
- 3 **ROOF DETAIL** SCALE: 1 1/2" = 1'-0"
- 2 **ROOF DETAIL** SCALE: 1 1/2" = 1'-0"
- 1 **ROOF DETAIL** SCALE: 1 1/2" = 1'-0"

**NOTE:**  
SEE PLUMBING AND MECHANICAL DRAWINGS FOR VENT STACKS LOCATIONS AND ADDITIONAL ROOF PENETRATIONS.  
PATCH AND REPAIR ROOF TO PROVIDE LEAKPROOF CONDITION AT ALL MECHANICAL EQUIPMENT LOCATIONS. (V.J.F. /MECH.)  
SEE MECHANICAL PLANS FOR ROUTING OF EXPOSED PIPE & DUCT RUNS ON EXISTING OR NEW ROOF AREAS AND SEE DETAIL SHEETS H202, H203 & H204 FOR ROOF CURB & ROOF PENETRATION DETAILS AND FOR PIPE SUPPORT CURB SPACING.

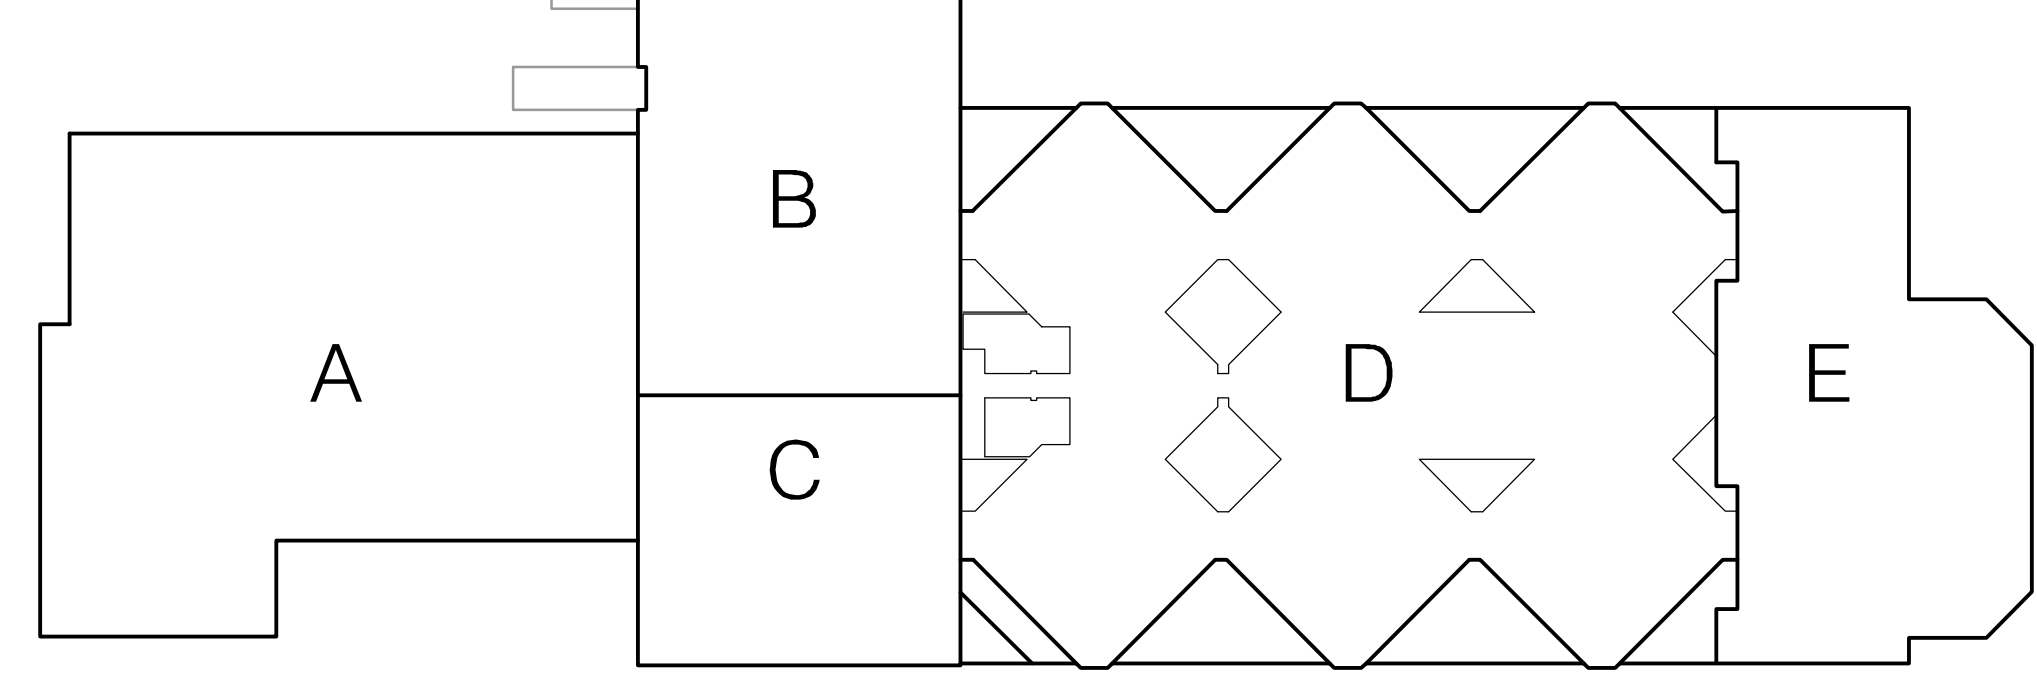

**KEY PLAN**  
NO SCALE

**ADULT DETENTION FACILITY EXPANSION**  
**THE COUNTY OF WILL**  
98 SOUTH CHICAGO STREET  
JOLIET, ILLINOIS 60432  
**WILL COUNTY BOARD**  
**BUILDING COMMISSION**

**ROOF PLAN**

PROJECT NO. 090413  
DATE: 11/20/2018  
DRAWN: J. SMITH  
CHECKED: J. SMITH  
APPROVED: J. SMITH

CIVIL ENGINEERS:  
**SMITH ENGINEERING CONSULTANTS, INC.**  
217.351.7036  
NEW LENOX, ILLINOIS 60451  
815.462.0324

CORRECTIONS & SECURITY CONSULTING:  
**KIMME & ASSOCIATES**  
217.351.7036  
NEW LENOX, ILLINOIS 60451  
815.462.0324

ARCHITECT OF RECORD:  
**STROMLAND AND DE YOUNG ARCHITECTS, INC.**  
217.351.7036  
NEW LENOX, ILLINOIS 60451  
815.462.0324

STRUCTURAL & MEP ENGINEERS:  
**TENG & ASSOCIATES, INC.**  
312.616.0000  
CHICAGO, ILLINOIS 60601

PROJECT MANAGEMENT:  
**SMITH ENGINEERING CONSULTANTS, INC.**  
217.351.7036  
NEW LENOX, ILLINOIS 60451  
815.462.0324

CONTRACT NO. 18-00447